


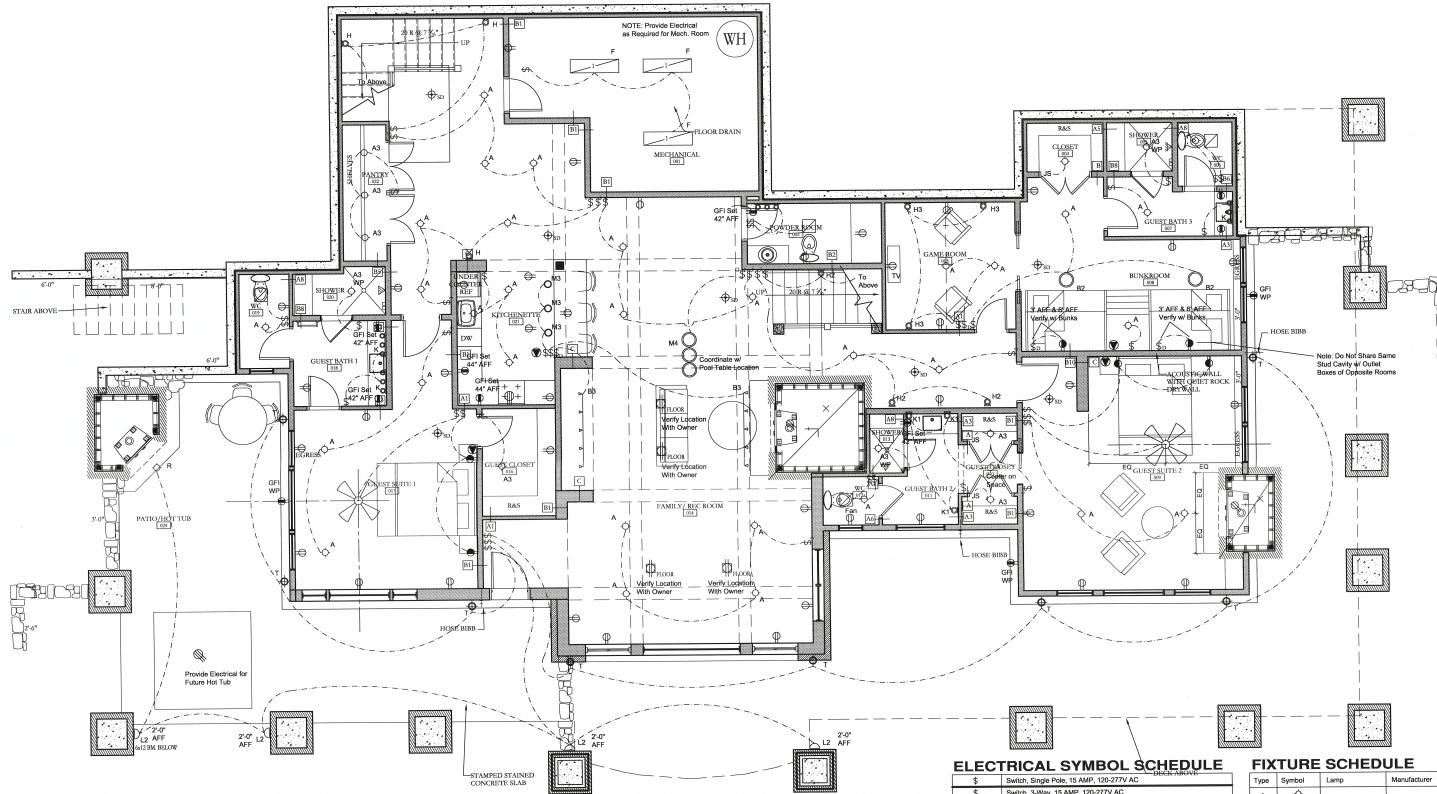

ELECTRICAL SYMBOL SCHEDULE

1	Switch, Single Pole, 15 AMP, 120-277V AC
2	Switch, 3-Way, 15 AMP, 120-277V AC
3	Switch, 4-Way, 15 AMP, 120-277V AC
4	Switch, Dimmer
5	Switch, Water Proof
6	Switch, Motion Sensor
7	Switch, Remote Control
8	Duplex Receptacle 15 AMP, 125V AC
9	Switched Receptacle 15 AMP, 125V AC
10	240V AC Receptacle (Verify Blade Configuration)
11	Direct Wire to Major Appliances
12	Telephone Jack Cat-5 Wire
13	Door Chime
14	Push Button
15	Gas Line
16	Smoke Detector, Hard Wired, Battery Back-Up
17	Ceiling Fan
18	Garage Door Opener
19	Plaster Patch
20	SPA Master
21	Single Light Dimmer
22	Lighting Master Dimmer
23	Lighting Multi-Set Joint Room Controls
24	Remote
25	Ceiling Exhaust Fan, Panasonic Whisper Ventilation Fan
26	Supply Fan

- NOTES:
1. OUTLETS BELOW WINDOWS TO BE CENTERED ON WINDOWS (TYP)
 2. COORDINATE OUTLETS AT VANITIES W/ HEIGHT OF BACKSPLASH
 3. PROVIDE LOW TEMPERATURE SENSORS
 4. PROVIDE CORROSION MONITORING SENSOR
 5. INTEGRATE SMOKE DETECTORS
 6. ALL LIGHT FIXTURES INSTALLED IN SHOWERS TO BE WATERPROOF

FIXTURE SCHEDULE

Type	Symbol	Lamp	Manufacturer	Fixture #	Description
A	◇	60W PAR 20	Halo	H5CAT-600T8Z	Recessed Downlight
A1	◇	50W 12V MR16	Halo	H1496IC-1496T8Z	Low Voltage Recessed Adjustable
A2	◇	50W 12V MR16	Halo	H1496IC-1419T8Z	Low Voltage Lensed Recessed Downlight
A3	◇	50 W PAR 30	Halo	H7CT-12T8ZS	Lensed Recessed Downlight
A4	◇	50W 12V MR16	Halo	H1496IC-1851T8ZS	Low Voltage Recessed Downlight
B1	○	42W MR16	Vision 3	FLS-AGE-C2-K1-15202-L14-2	Surface Mounted Adjustable
B2	○	(2)100W med	TBD	TBD	Surface Mounted Fixture
B3	—v—v—v—	GL10	WAC Lighting	TBD	Surface Mounted Track Fixture
C	—		TBD	TBD	Undercabinet Lighting
H	□	(2)	TBD	TBD	Interior Wall Sconce Provided by Owner - Stairs 102
H1	□	(1)	TBD	TBD	Interior Wall Sconce Provided by Owner - Stairs 105
H2	□	(8 or 6)	TBD	TBD	Interior Wall Sconce Provided by Owner - Lower Level
H3	□	TBD	TBD	TBD	Interior Wall Sconce - Lower Game Room & Phase 2
K	□		TBD	TBD	Wall Mount Bath Fixture - 3 Light
K1	□		TBD	TBD	Wall Mount Bath Fixture - 1 Light
K4	□		TBD	TBD	Wall Mount Bath Fixture - 4 Light
P	○		TBD	TBD	Pendant Fixtures - Dining
M	○		TBD	TBD	Pendant Fixtures - Great Room
M1	○		TBD	TBD	Small Pendant Fixtures - ENTRY
M2	○		TBD	TBD	Pendant - SITTING AREAS
M3	○		TBD	TBD	Pendant - KITCHEN BAR
M4	○		TBD	TBD	Pendant - POOL TABLE
F	□	(2)32W T8	Metalux	2004-REB1	1" T 8" Van Lamp 18" w/rapid Start Electronic Ballast
R	□	50W MR16	TEKA	DWM-6316-BP	Exterior Surface Mount Adjustable
S	—		TBD	TBD	Wall Mount Fluorescent
T	□		TBD	TBD	Exterior Wall Mounted Lamp
U	□		TBD	TBD	Exterior Post Mounted Lamp
L	◇		TBD	TBD	Decorative Landscape Fixture - at Front
L2	◇		TBD	TBD	Decorative Landscape Fixture - Strip Light
L3	○		TBD	TBD	Landscape Fixture
PP	□		TBD	TBD	Exterior Pendant - Entry

LOWER LEVEL ELECTRICAL PLAN

G.S.F. = 3370
S.F. = 2230
MECH = 304

Issued For: Due:
100% S.D. 06/08/07
DRM REVIEW 07/06/07

Drawn By: T. Shaw
Date: November 05, 2007
Project #: 0322.01
Phase: 95% C.D.
Sheet:

E1-1.0

LOWER LEVEL
ELECTRICAL PLAN