

COLORADO:
10831 EAGLE CREST LANE
PARKER, COLORADO 80138
P 303.840.0020
F 303.840.2299

MONTANA:
P.O. BOX 161488
11 LONE PEAK DR., UNIT 206
BIG SKY, MONTANA 59716
P 406.995.7572
F 406.995.7477

www.centresky.com

STAUDER RANCH
LOT 7 - SAN JUAN RANCH
814 HULL RIDGE ROAD
MONTROSE, COLORADO 81401


NOT FOR
CONSTRUCTION

Issued For	Date
- 100% S.D.	06/08/07
- DRB REVIEW	07/06/07

Drawn By	T. Sauer
Date	November 06, 2007
Project #	0622.01
Phase	95% C.D.
Sheet	

E1-1.1b

GARAGE/ UPPER
ELECTRICAL PLAN

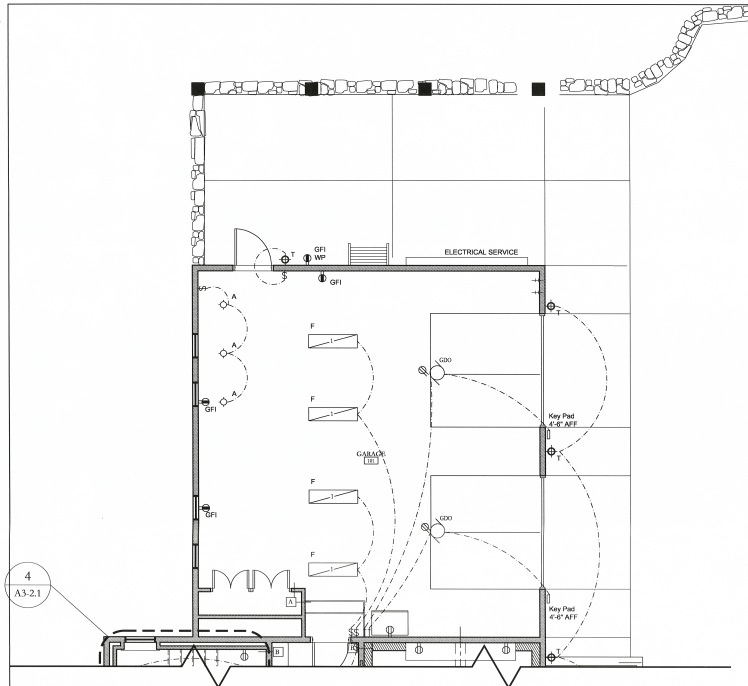


 1 GARAGE ELECTRICAL PLAN
1/4" = 1'-0"
S.F. = 846

ELECTRICAL SYMBOL SCHEDULE

S	Switch, Single Pole, 15 AMP, 120-277V AC
S	Switch, 3-Way, 15 AMP, 120-277V AC
S	Switch, 4-Way, 15 AMP, 120-277V AC
S	Switch, Chime
S	Switch, Water Proof
S	Switch, Motion Sensor
S	Switch, Decade Control
D	Duplex Receptacle 15 AMP, 125V AC
D	GFI Receptacle 15 AMP, 120V AC
D	Switched Receptacle 15 AMP, 125V AC
D	Fluor Receptacle 15 AMP, 125V AC
D	240V AC Receptacle (Verly Blade Configuration)
D	Draw Wire to Motor Appliances
C	Telephone Jack Cat 6 Wire
I	Door Chime
—H—	Push Button
—G—	Close Line
	Smoke Detector, Hard Wired, Battery Back-Up
	Ceiling Fan
	Garage Door Opener
	Brassware Plating
(M)	RIA Motor
D11	Staple Load Limiter
D12	Load Limiter, Domestic
D13	Load Limiter, Multi-Spot, Room Controls
R	Remote
	Control Panel Fan, Panasonic Whisper Ventilation Fan
	Supply Fan

1. OUTLINE

 1. OUTLETS BELOW WINDOWS TO BE CENTERED ON WINDOWS (TYP)
2. COORDINATE OUTLETS AT VANITIES W/ HEIGHT OF BACKSPLASH
3. PROVIDE LOW TEMPERATURE SENSORS
3. PROVIDE CARBON MONOXIDE SENSOR
4. INTEGRATE SMOKE DETECTORS
5. ALL LIGHT FIXTURES INSTALLED IN SHOWERS TO BE WATERPROOF



FIXTURE SCHEDULE

Type	Symbol	Lamp	Manufacturer	Fixture #	Description
A		50W PAR 20	Halo	HSCAT-5001TBZ	Recessed Downlight
A1		50W 12V MR16	Halo	H149BC-149BTBZ	Low Voltage Recessed Adjustable
A2		50W 12V MR16	Halo	H149BC-141BTBZ	Low Voltage Lensed Recessed Downlight
A3		50 W PAR 30	Halo	17NCT-172TBZ5	Lensed Recessed Downlight
A4		50W 12V MR16	Halo	H149BC-1561TBZ5	Low Voltage Recessed Downlight
B1		42W MR16	Vision 3	P15-AGE-32-1K 120-07-L1-0	Surface Mounted Adjustable
B2		(2)100w med	TBD	TBD	Surface Mounted Fixture
B3		WAC Lighting	TBD	TBD	Surface Mounted Track Fixture
C		GU10	TBD	TBD	Undercabinet Lighting
H		(2)	TBD	TBD	Interior Wall Sconce Provided by Owner - Stairs - 102
H1		(1)	TBD	TBD	Interior Wall Sconce Provided by Owner - Stairs - 105
H2		(5 or 6)	TBD	TBD	Interior Wall Sconce Provided by Owner - Lower Level
H3		TBD	TBD	TBD	Interior Wall Sconce - Lower Game Room & Phase 2
K		-	TBD	TBD	Wall Mount Bath Fixture - 3 Light
K1		-	TBD	TBD	Wall Mount Bath Fixture - 1 Light
K4		-	TBD	TBD	Wall Mount Bath Fixture - 4 Light
P		-	TBD	TBD	Pendant Fixture - Dining
M		-	TBD	TBD	Pendant Fixtures - Great Room
M1		-	TBD	TBD	Small Pendant Fixtures - ENTRY
M2		-	TBD	TBD	Pendant - SITTING AREAS
M3		-	TBD	TBD	Pendant - KITCHEN BAR
M4		-	TBD	TBD	Pendant - POOL TABLE
R		(2)32W T8	Metalux	2004-REB1	1' X 4' Two Lamp T8 with/less Ball Electronic Ballast
F		50W MR16	TDKA	DWM-6316-BP	Exterior Surface Mount Adjustable
S		-	TBD	TBD	Wall Mount Fluorescent
T		-	TBD	TBD	Exterior Wall Mounted Lamp
U		-	TBD	TBD	Exterior Post Mounted Lamp
L		-	TBD	TBD	Decorative Landscape Fixture - at Front
L2		-	TBD	TBD	Decorative Landscape Fixture - Step Light
L3		-	TBD	TBD	Landscape Fixture
PP		-	TBD	TBD	Exterior Pendant - Entry

